


REF. DWG.	-
CABLE No	-/-
SIZE	35mm ² 4C SWA
FROM	ELECTRICAL SUBSTATION
CIRCUIT No	-

REFERENCE DRAWINGS	
DWG. NO	DRAWING TITLE
RD02-94002	MDB02 SINGLE LINE DIAGRAM
RD02-94003	UPS-DB01 SINGLE LINE DIAGRAM
RD02-98001	LIGHTING LAYOUT
RD02-98002	SMALL POWER LAYOUT

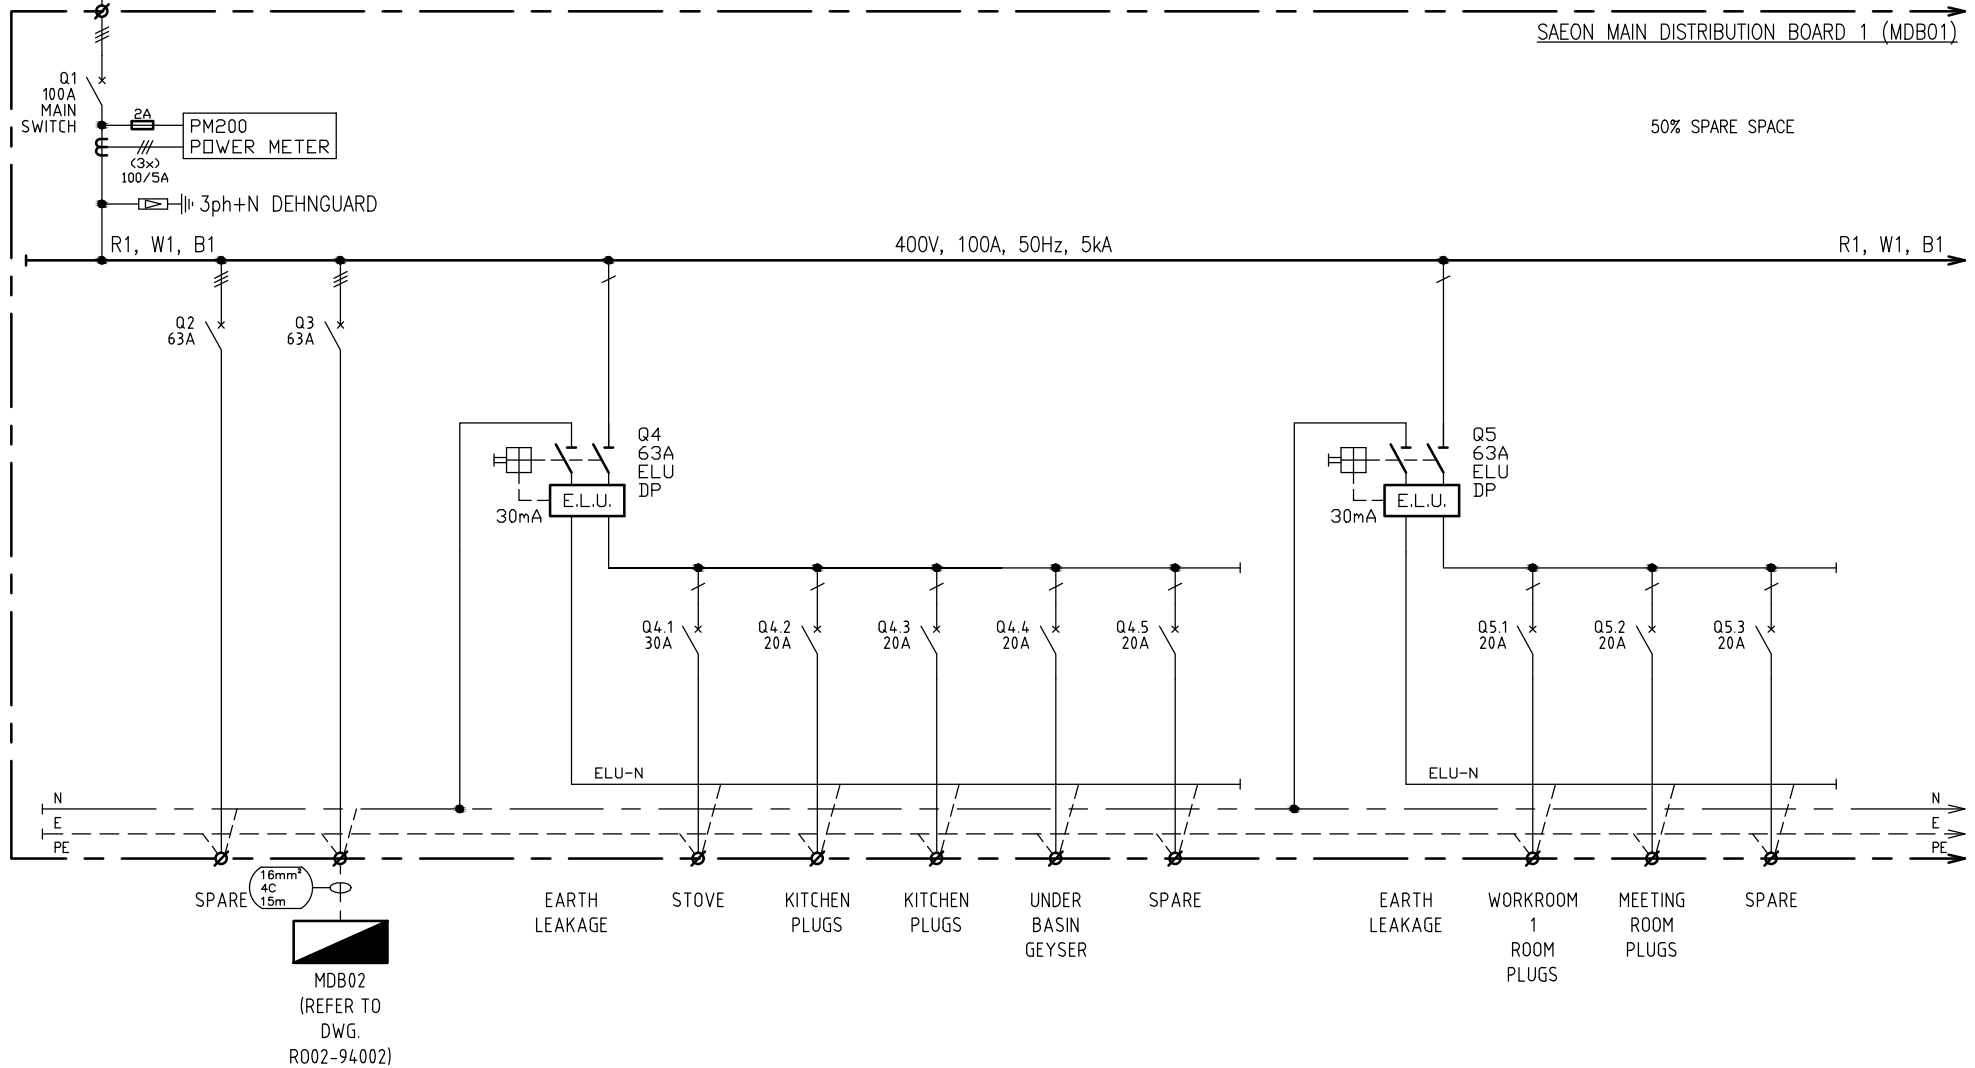

-	1	2	3	4	5	6	7	8	005	9	10	11	12	13	14	15	16	010
---	---	---	---	---	---	---	---	---	-----	---	----	----	----	----	----	----	----	-----

CONSULTANT:



TEL. (021) 914 6385
FAX. (021) 914 6328


DEPOT MANAGER/CLIENT:



REV	DESCRIPTION	DRAWN	DATE	CHKD	APP
0A	ISSUED FOR COMMENT	MC	17/09/18	MHM	JGP
0B	UPDATED	MHM	15/03/19	MHM	JGP

PROJECT:	NEW OFFICE FOR SAEON BUILDING
TITLE:	MAIN DISTRIBUTION BOARD MDB01 SINGLE LINE DIAGRAM SHEET 1 OF 3

DESIGN	DRAWN	SCALE	DATE	SIZE
JGP	MC	N.T.S.	03/09/18	A3
DWG No:		RD02-94001		Rev: 0B

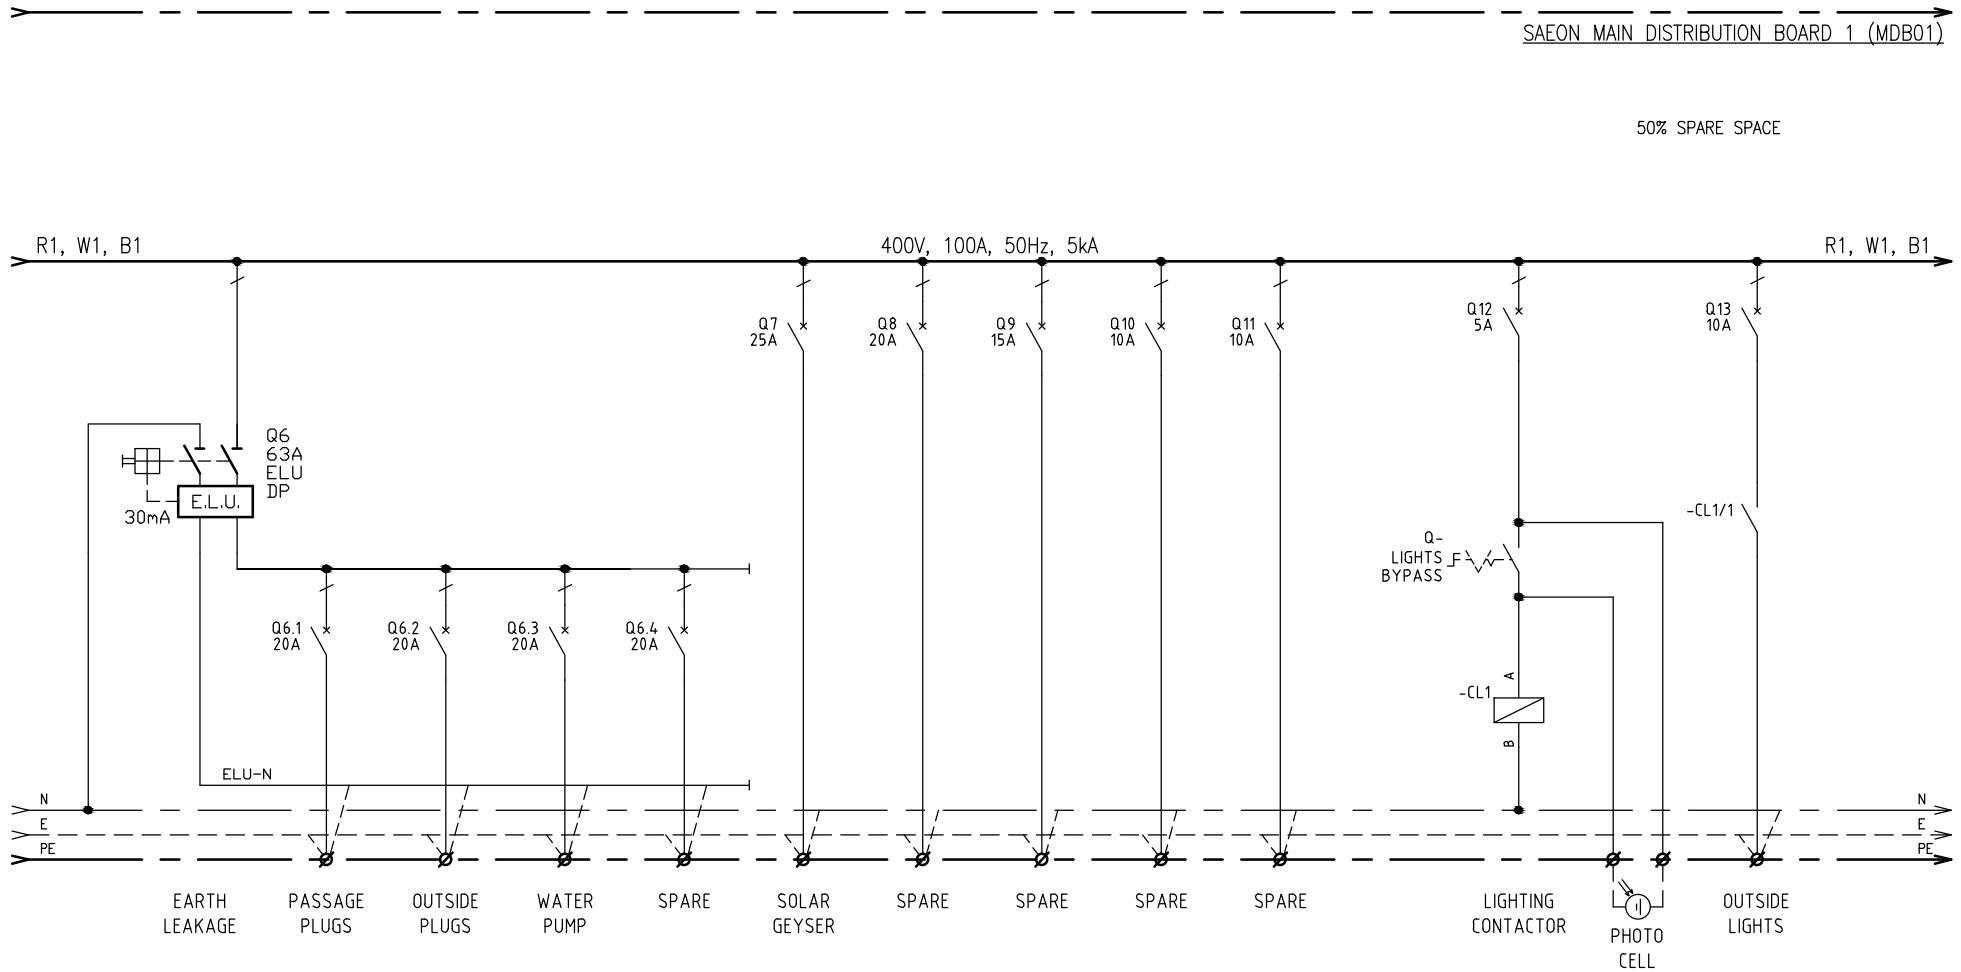

005 1 2 3 4 5 6 7 8 010 9 10 11 12 13 14 15 16 015

CONSULTANT:




DEPOT MANAGER/CLIENT:



REV	DESCRIPTION	DRAWN	DATE	CHKD	APP
0A	ISSUED FOR COMMENT	MC	17/09/18	MHM	JGP
0B	UPDATED	MHM	15/03/19	MHM	JGP

PROJECT:	NEW OFFICE FOR SAEON BUILDING
TITLE:	MAIN DISTRIBUTION BOARD MDB01 SINGLE LINE DIAGRAM SHEET 2 OF 3

DESIGN	DRAWN	SCALE	DATE	SIZE
JGP	MC	N.T.S.	03/09/18	A3
DWG No:	R002-94001			Rev: 0B

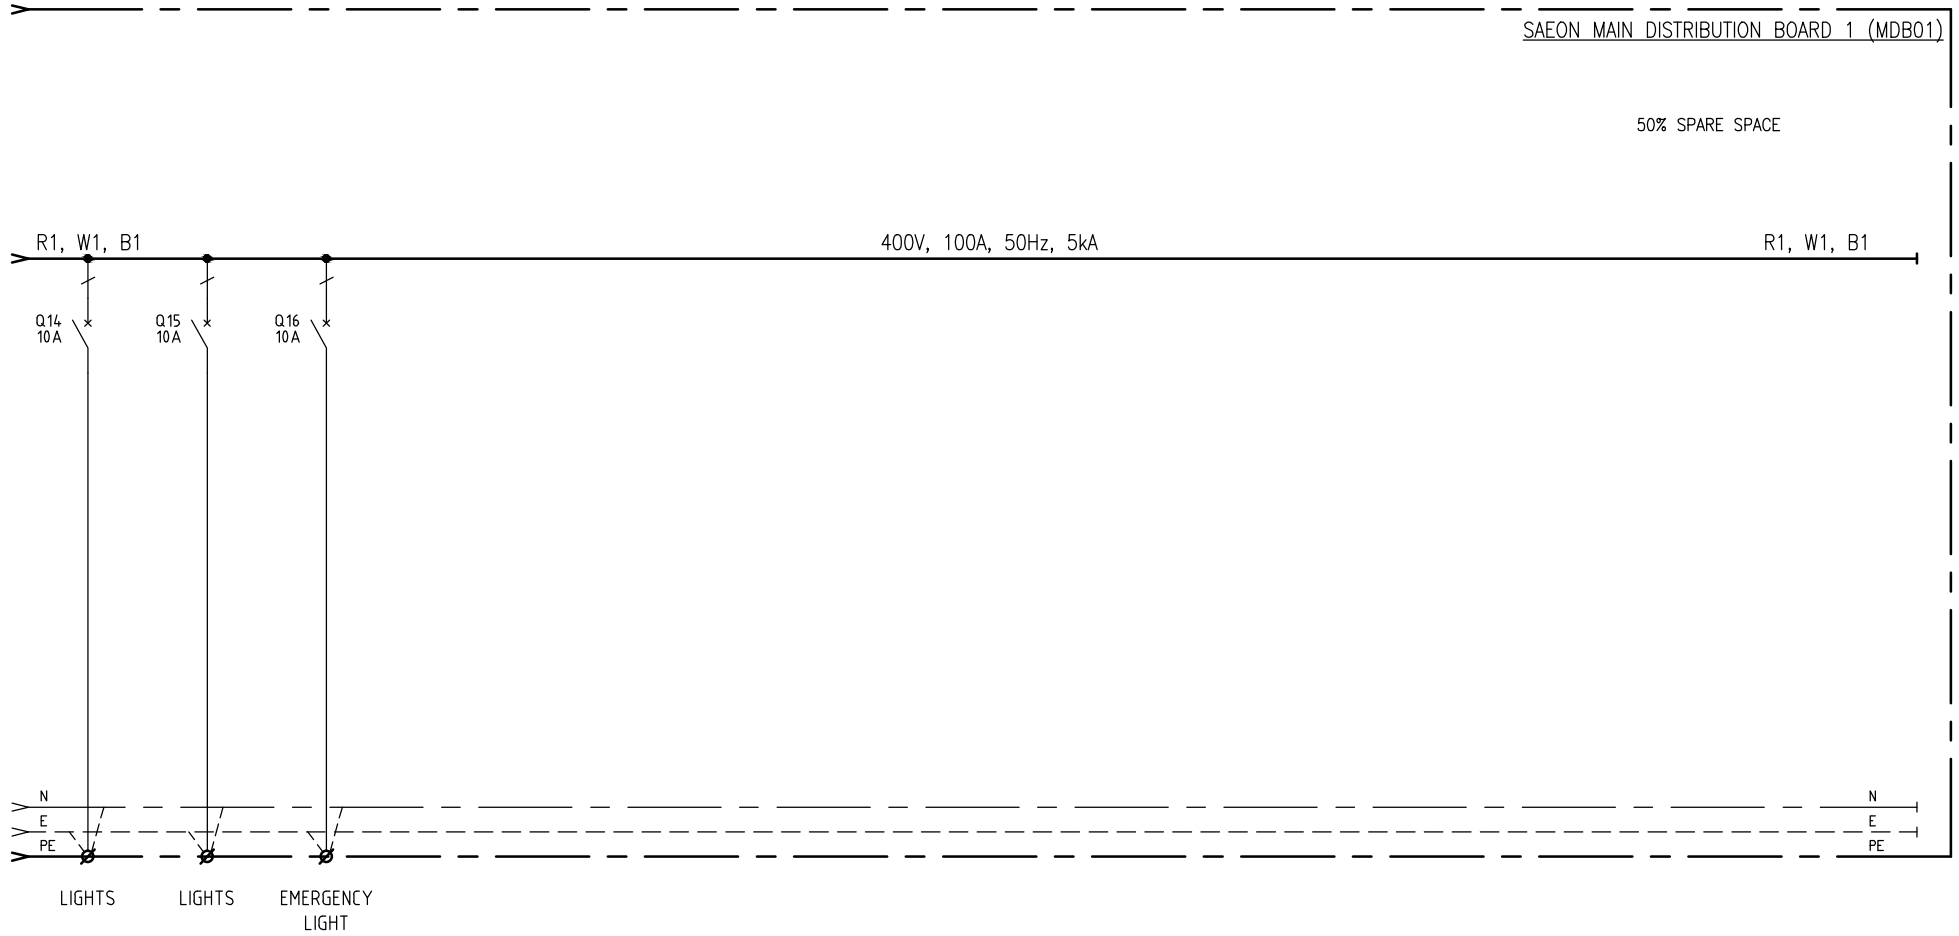

010 1 2 3 4 5 6 7 8 015 9 10 11 12 13 14 15 16 -

CONSULTANT:



TEL. (021) 914 6385
FAX. (021) 914 6328

DEPOT MANAGER/CLIENT:



REV	DESCRIPTION	DRAWN	DATE	CHCKD	APP
0A	ISSUED FOR COMMENT	MC	17/09/18	MHM	JGP
0B	UPDATED	MHM	15/03/19	MHM	JGP

PROJECT:
NEW OFFICE FOR SAEON BUILDING

TITLE:
MAIN DISTRIBUTION BOARD
MDB01
SINGLE LINE DIAGRAM
SHEET 3 OF 3

DESIGN	DRAWN	SCALE	DATE	SIZE
JGP	MC	N.T.S.	03/09/18	A3
DWG No: R002-94001			Rev: 0B	