


REFERENCE DRAWINGS	
DWG. NO	DRAWING TITLE
RD02-98004	SMALL POWER & LIGHTING LAYOUT

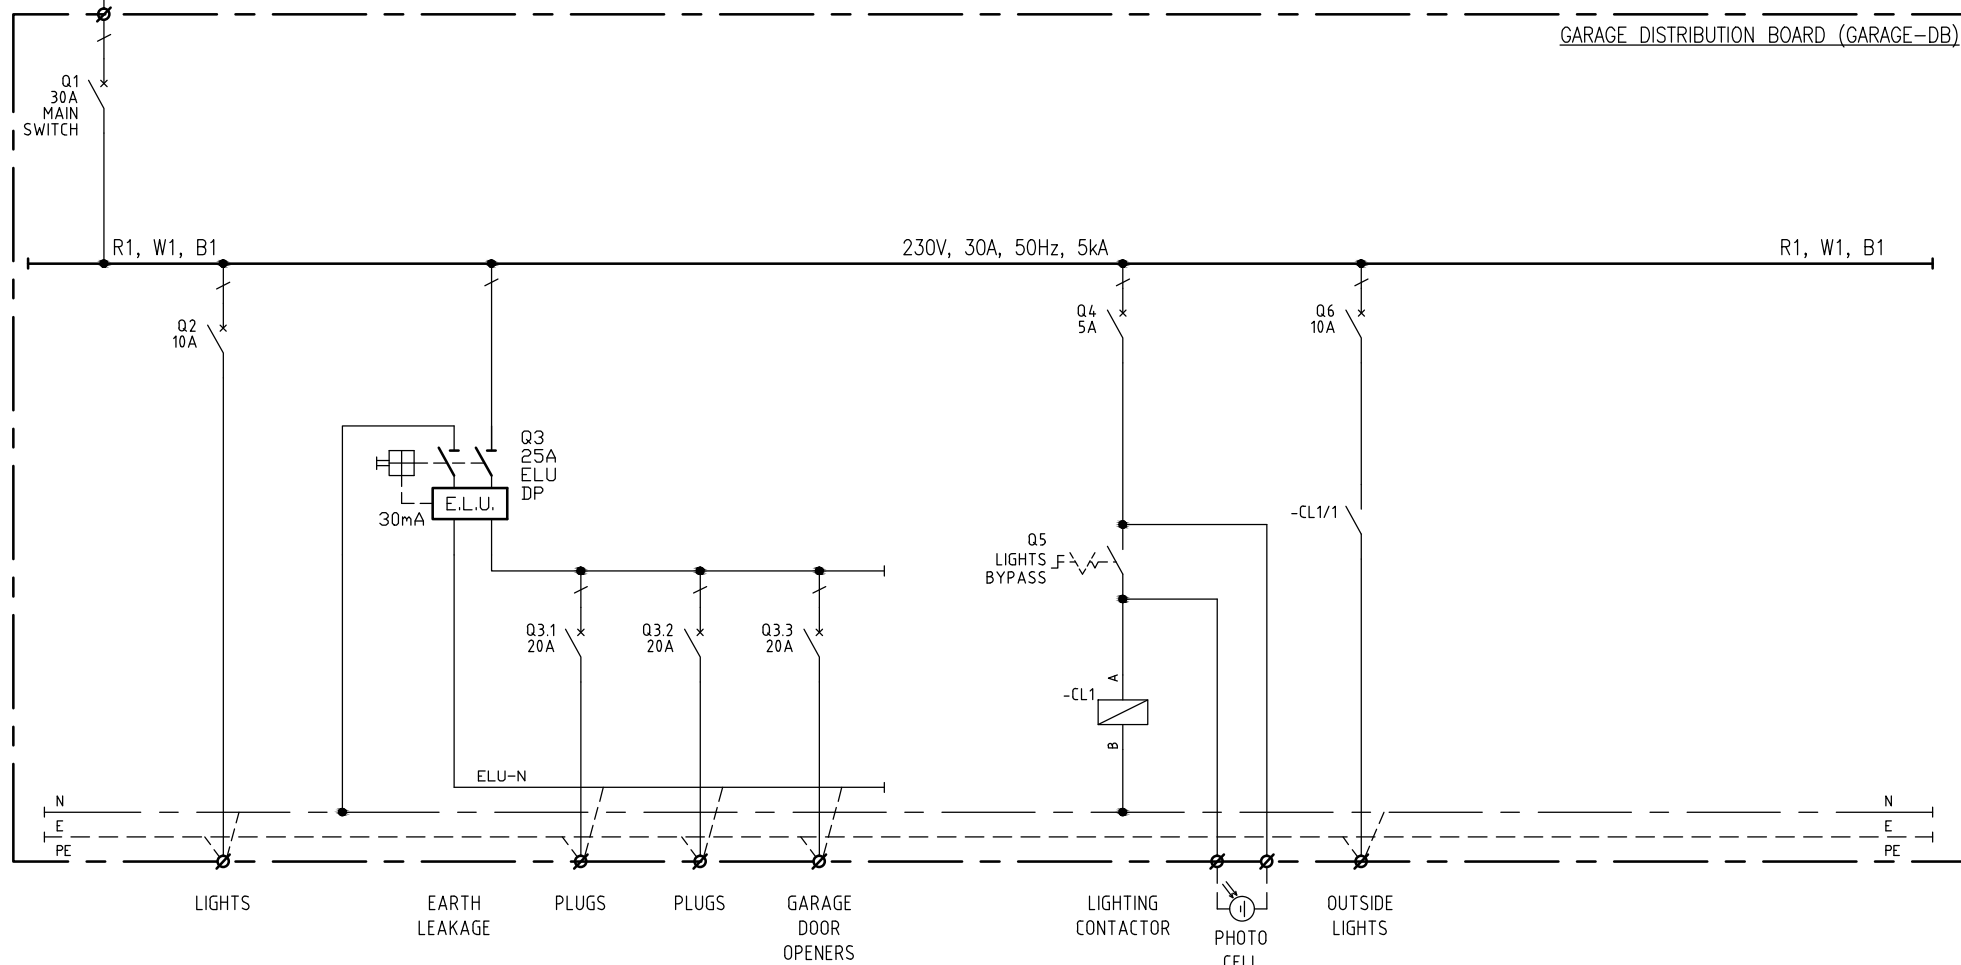

CONSULTANT:



TEL. (021) 914 6385
FAX. (021) 914 6328

DEPOT MANAGER/CLIENT:



REV	DESCRIPTION	DRAWN	DATE	CHKD	APP
0A	ISSUED FOR COMMENT	MC	17/09/18	MHM	JGR
0B	UPDATED	MHM	15/03/19	MHM	JGR

PROJECT:

OFFICE FOR SAEON BUILDING

GARAGE DISTRIBUTION BOARD
GARAGE-DB
SINGLE LINE DIAGRAM

DESIGN	DRAWN	SCALE	DATE	SIZE
JGP	MC	N.T.S.	03/09/18	A3
DWG No:		R002-94005	Rev: 0B	